


OVERHANG DIMENSION (*)			
ROOF PITCH	HOUSE WIDTH		
	24'-0"	26'-0"/30'-0"	27'-8"/31'-8"
5/12	16"	11"	16"
7/12	16"	11"	16"
9/12	12"	11"	12"
12/12	8 3/4"	8 3/4"	8 3/4"

NOTE:
WINDOW GRILLE PATTERNS SHOWN ARE FOR ANDERSEN WINDOWS.
GRILLE PATTERNS FOR OTHER MANUFACTURERS MAY BE DIFFERENT.




ALL EXT. STAIRS, STEPS, RAILS & GUARDS TO BE DESIGNED, SUPPLIED AND INSTALLED BY B/P


FRONT ELEVATION

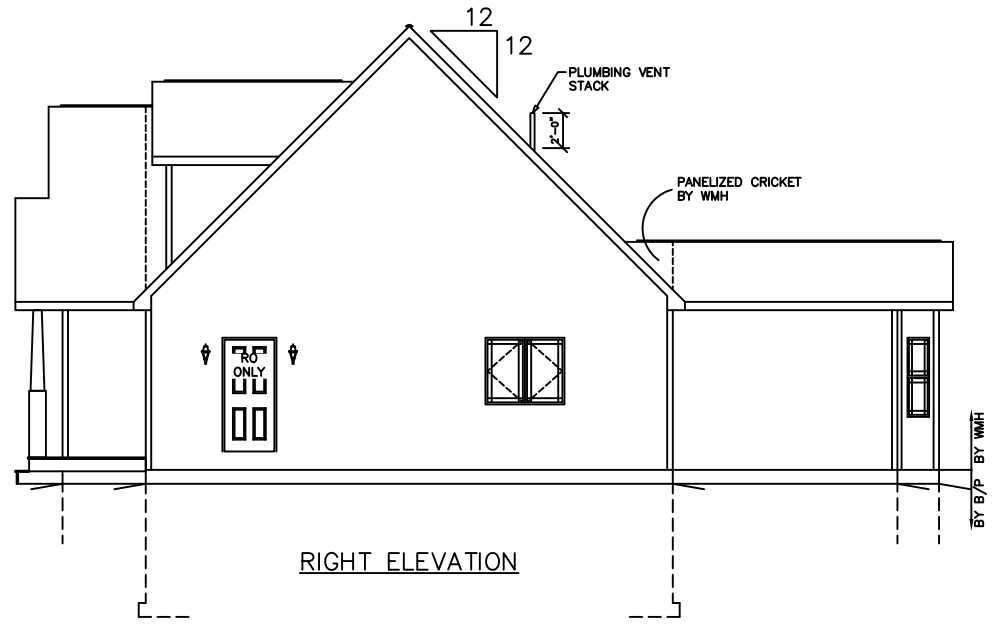

RIGHT ELEVATION

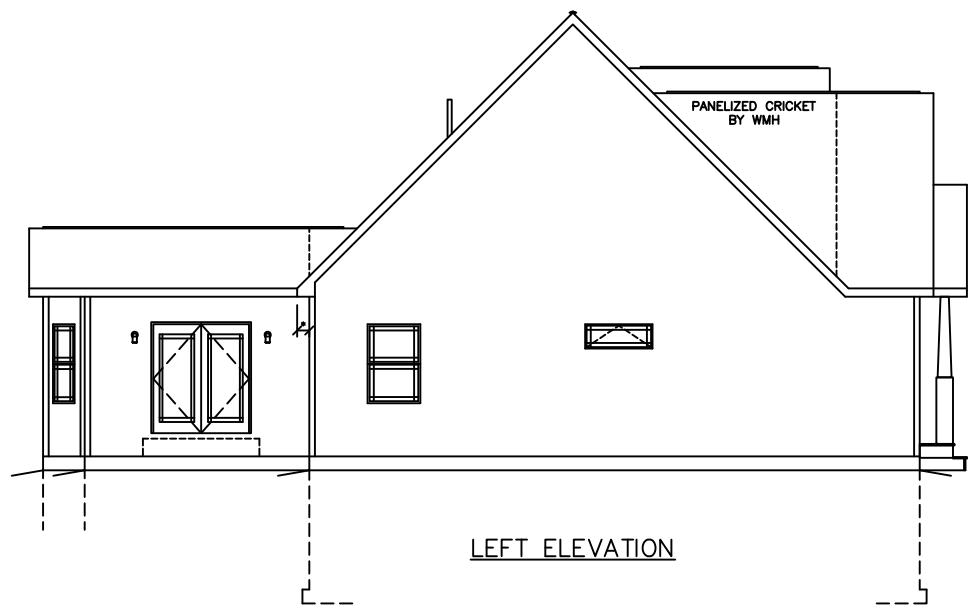

LEFT ELEVATION

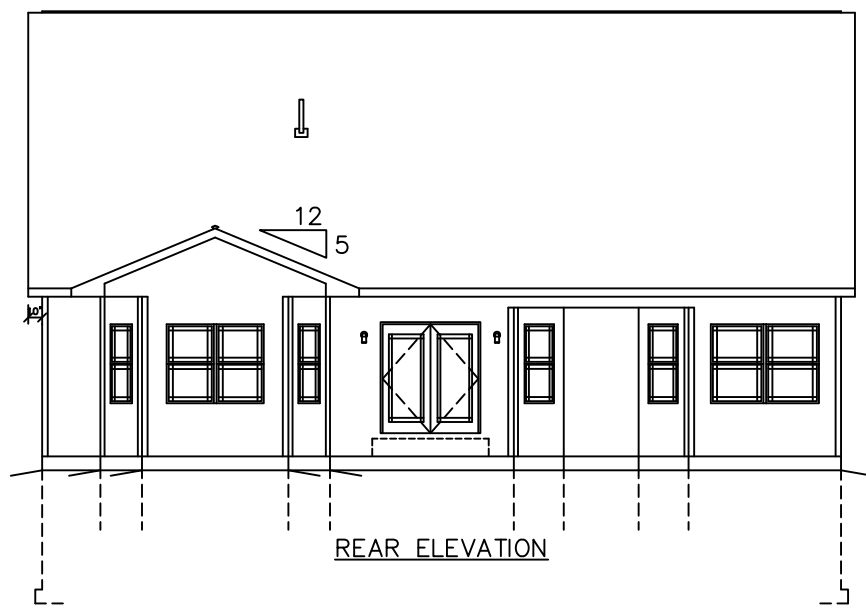

REAR ELEVATION

SEE STANDARD NOTES & DETAILS DWG #8


USE GROUP: R5	BUILDER: HOMEOWNER:	SERIAL No. 11030	THIRD PARTY INSPECTION AGENCY
CONST. TYPE: VB		PRODUCTION No. 5839	PE / RA
DESIGNER: P. McHUGH		REVISION	
DATE: 4/7/11		P. McHUGH	DATE: 6/20/11
SCALE: 1/8" = 1'-0"		P. McHUGH	DATE: 8/11/11
PAGE: 1		CHECK	DATE
		V. GIORGIO	10/12/07

CAPE ELEVATIONS CTM-R

Westchester Modular Homes Inc
30 Reagans Mill Road, Wingdale, New York, 12594
Tel (845)832-9400 Fax (845)832-6698

LIGHT & VENTILATION SCHEDULE (SF)			
ROOM	AREA	LIGHT SUPPLIED	VENT SUPPLIED
KITCHEN	201		
LIVING ROOM	169	*52-3*	A-O-O-B
DINING ROOM	164	20.6	11.46
MSTR BEDROOM	193	48.5	33.61
BEDROOM 2	141	41.2	22.92
BEDROOM 3	121	20.6	11.46

* ARTIFICIAL LIGHT TO BE SUPPLIED *

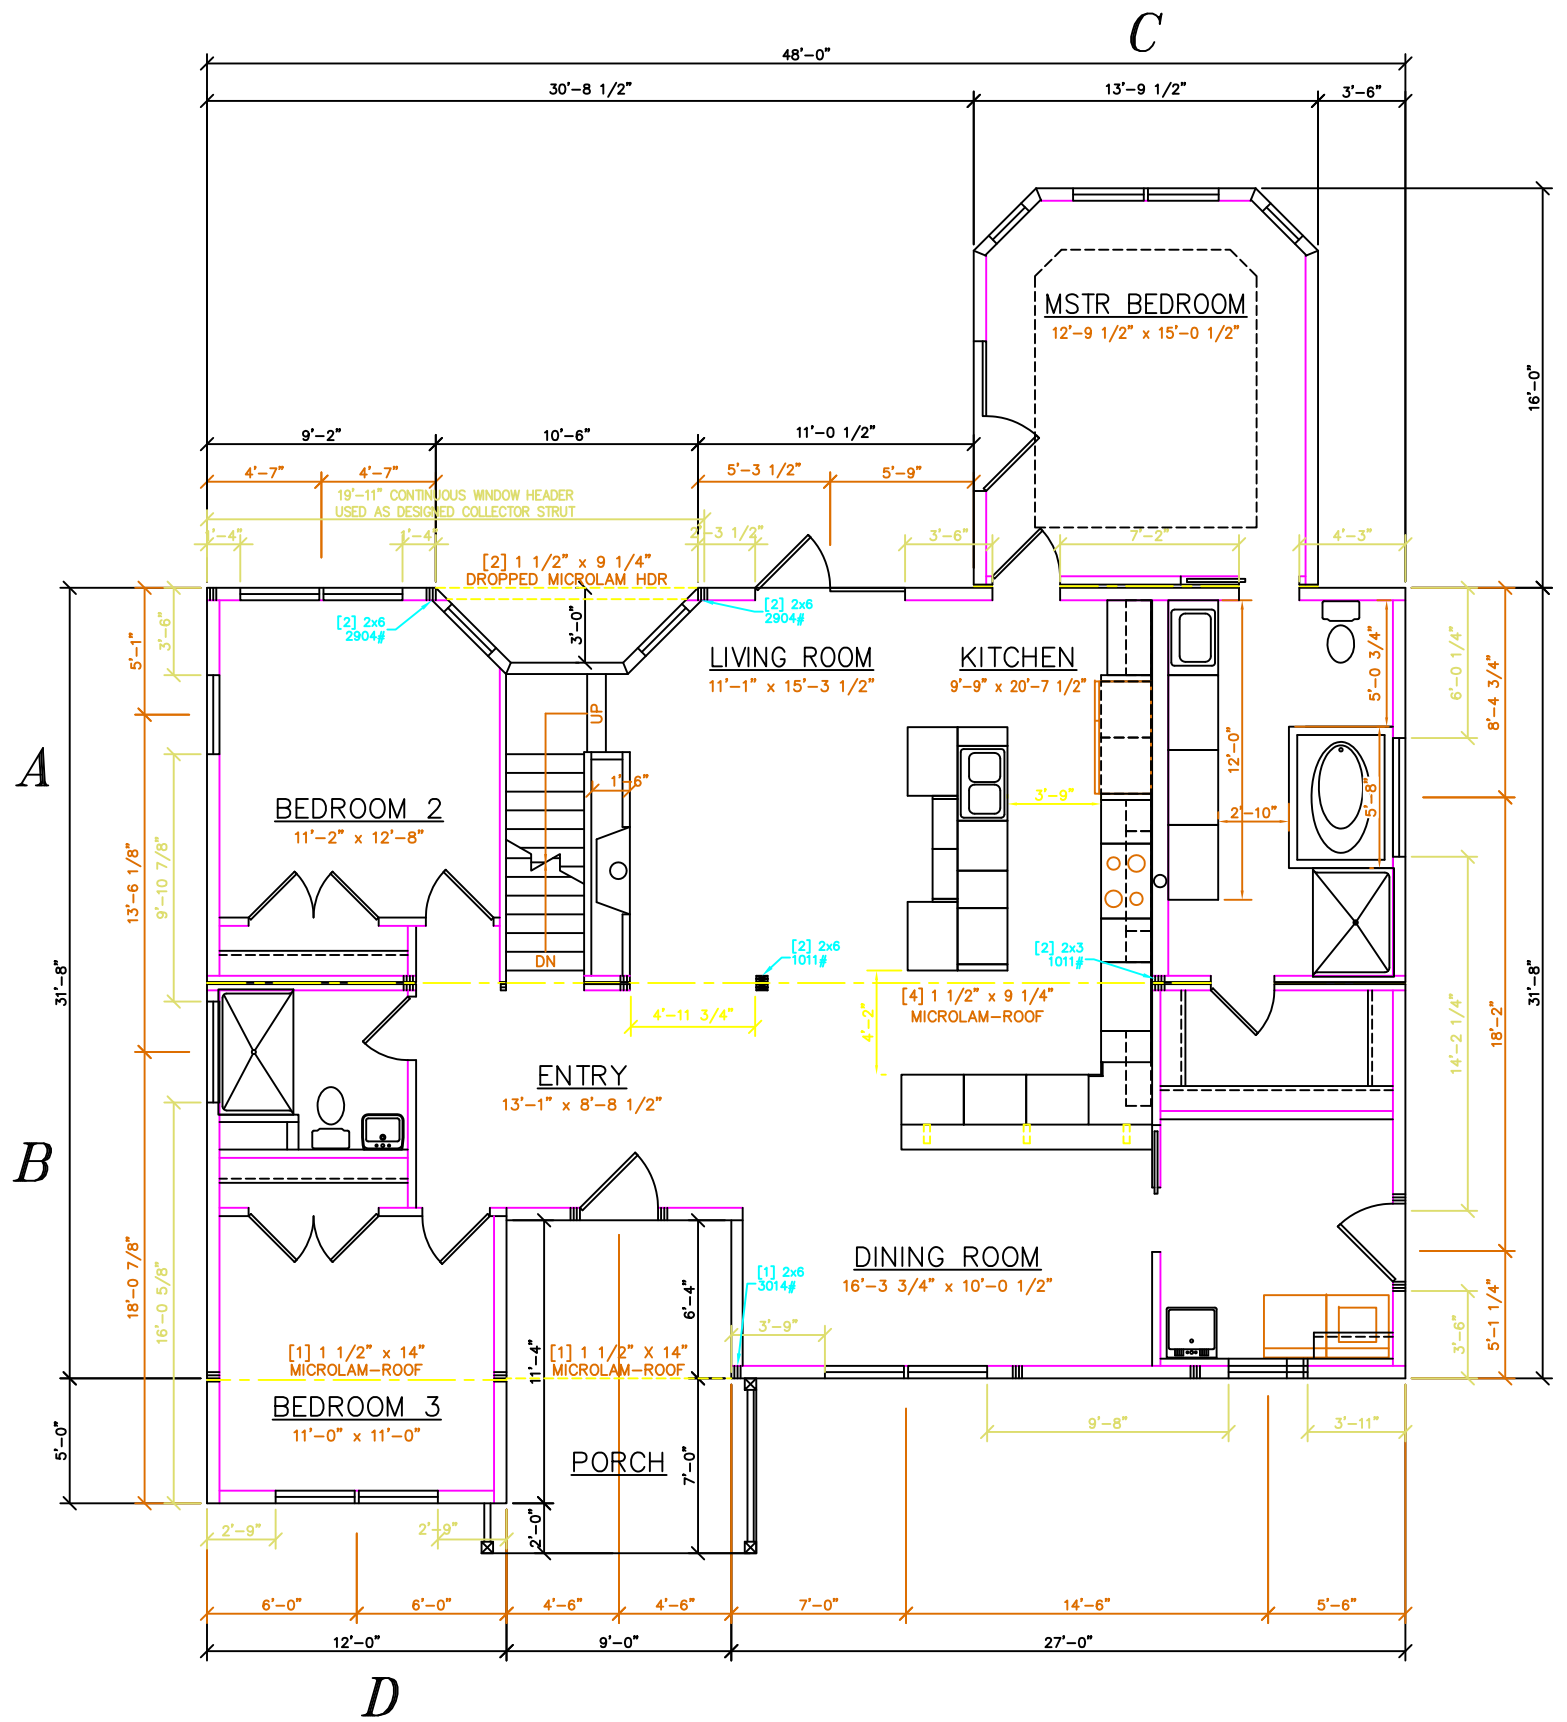


SEE STANDARD NOTES & DETAILS DWG #8

USE GROUP:	R5	BUILDER:	HOMEOWNER:
CONST. TYPE:	VB	SERIAL No.	11030
DESIGNER:	P. McHUGH	PRODUCTION No.	5839
DATE:	4/7/11	REVISION	P. McHUGH 6/20/11
SCALE:	3/16" = 1'-0"	DATE	P. McHUGH 8/11/11
PAGE:	3A	CHECK	DATE
		THIRD PARTY INSPECTION AGENCY	
		PE / RA	

CAPE CTM-R
FIRST FLOOR PLAN

Westchester Modular Homes Inc
 30 Reagans Mill Road, Wingdale, New York, 12594
 Tel (845)832-9400 Fax (845)832-6698

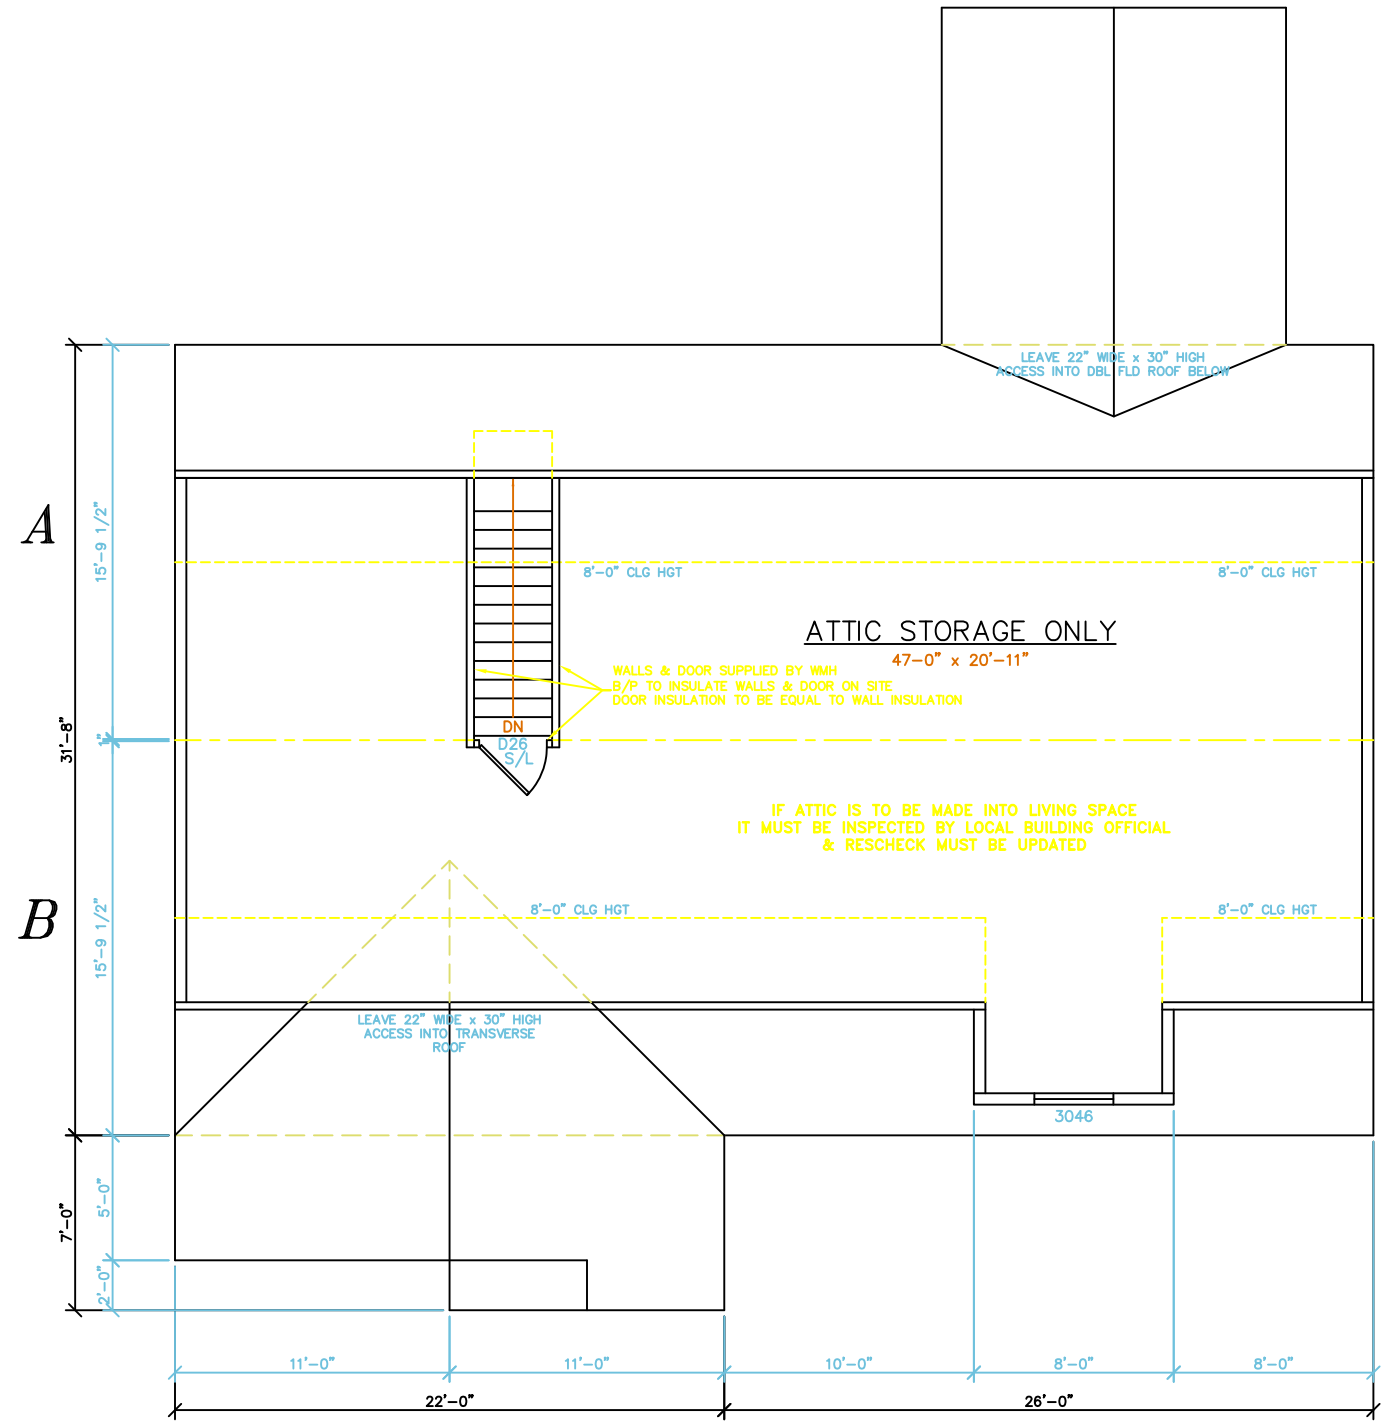

All design and construction of 2nd.floer is the on site responsibility of the builder and must be completed in accordance with local building code and inspection procedures. State approval of this project only pertains to the modular units as provided by Westchester Modular Homes Inc.

SEE STANDARD NOTES & DETAILS DWG #8

USE GROUP:	R5	BUILDER:	HOMEOWNER:	THIRD PARTY INSPECTION AGENCY:
CONST. TYPE:	VB	SERIAL No.	11030	PE / RA
DESIGNER:	P.McHUGH	PRODUCTION No.	5839	
DATE:	4/7/11	REVISION		
SCALE:	3/16" = 1'-0"	P.McHUGH	DATE	
PAGE:	3B	P.McHUGH	6/20/11	
			8/11/11	
		CHECK	DATE	

CARP
SECOND FLOOR PLAN
Westchester Modular Homes Inc
 30 Reagans Mill Road, Wingdale, New York, 12594
 Tel (845)832-9400 Fax (845)832-6698