
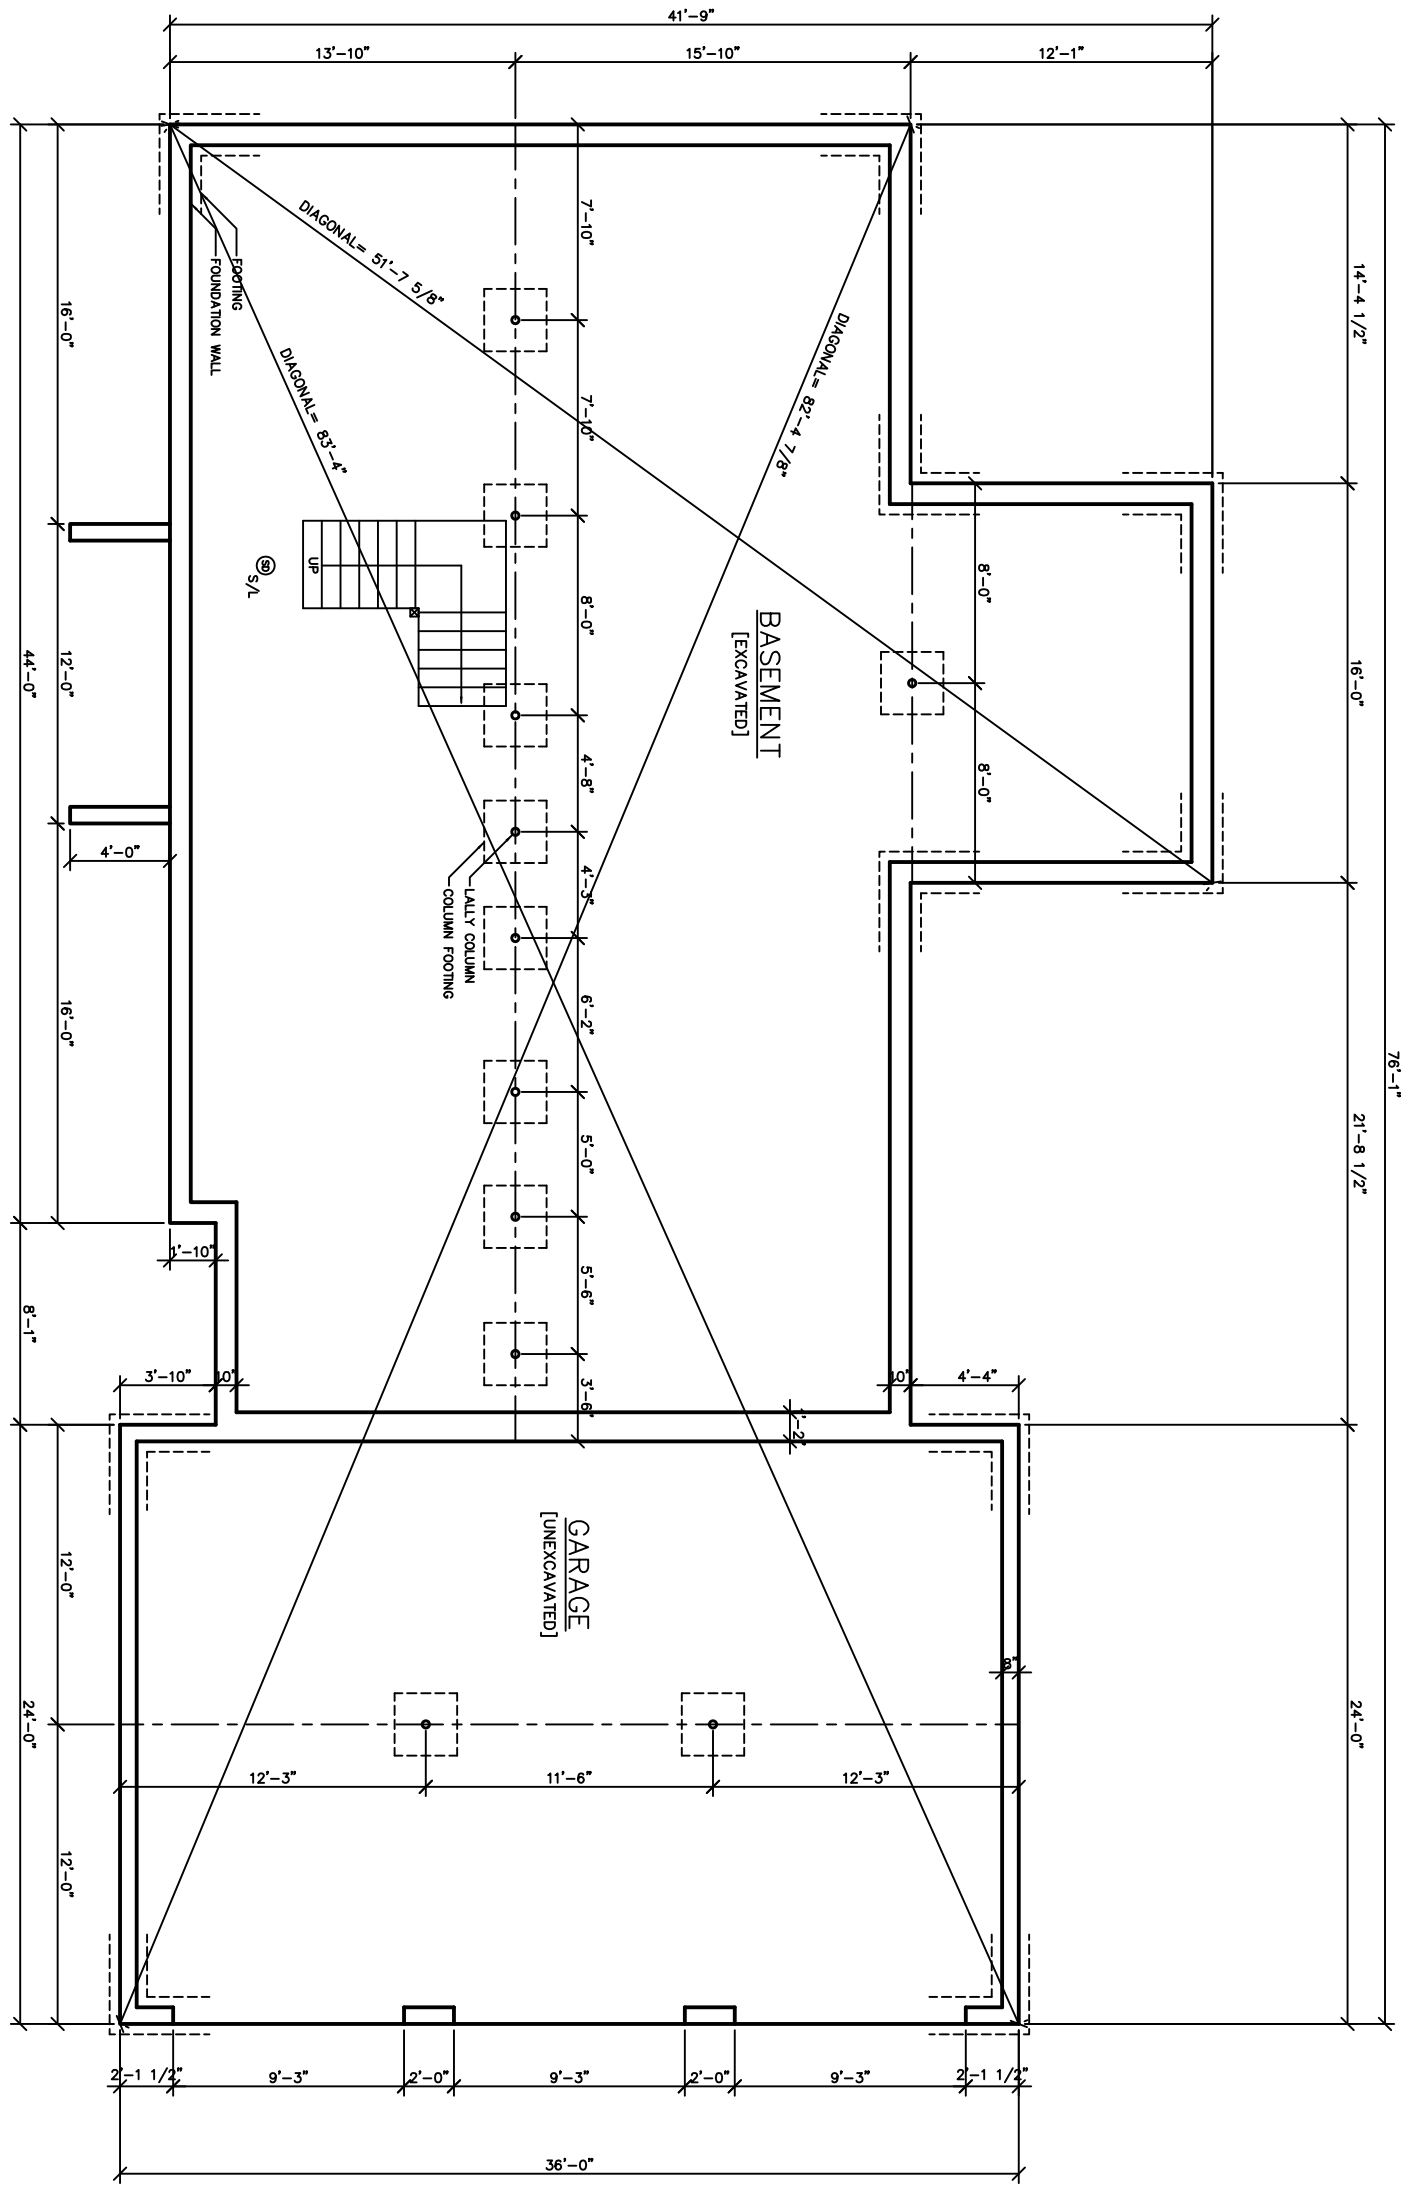



SEE STANDARD NOTES & DETAILS DWG #8


USE GROUP: <b>A1</b>	BUILDER: WMHCC	HOMEOWNER: MODEL	SERIAL No.	PE / RA	THIRD PARTY INSPECTION AGENCY	
CONST. TYPE: <b>5B</b>	2910 ROUTE 22 PATTERSON, NY 12563	SITE: ROUTE 22 BREWSTER, NY	PRODUCTION No.			
DESIGNER:	<b>GEORGETOWN</b> - L <b>ELEVATIONS</b>	REVISION	DATE			
DATE:						
SCALE: 1/8" = 1'-0"			CHECK	DATE		
PAGE: <b>1</b>		 <b>Westchester Modular Homes Inc</b> 30 Reagans Mill Road, Wingdale, New York, 12594 Tel (914)832-9400 Fax (914)832-6698	STD REVISION	01/19/02		



SEE STANDARD NOTES & DETAILS DWG #8

USE GROUP:	BUILDER:	HOMEOWNER:	SERIAL No.	PE / RA	THIRD PARTY INSPECTION AGENCY
CONST. TYPE:		SITE:	PRODUCTION No.		
DESIGNER:	<b>GEORGETOWN - L</b>		REVISION	DATE	
DATE:					
SCALE: 3/16" = 1'-0"	 <b>Westchester Modular Homes Inc</b> 30 Reagans Mill Road, Wingdale, New York, 12594 Tel (914)832-9400 Fax (914)832-6698		CHECK	DATE	
PAGE: <b>2</b>			STD REVISION	03/31/06	

LIGHT & VENTILATION SCHEDULE (SF)			
ROOM	AREA	LIGHT SUPPLIED	VENT SUPPLIED
LIVING ROOM	242	38.7	17.19
DINING ROOM	196	25.8	11.46
KIT/BKFT	320	40.2	21.63
FAMILY ROOM	320	51.6	22.92
STUDY	168	38.7	17.19

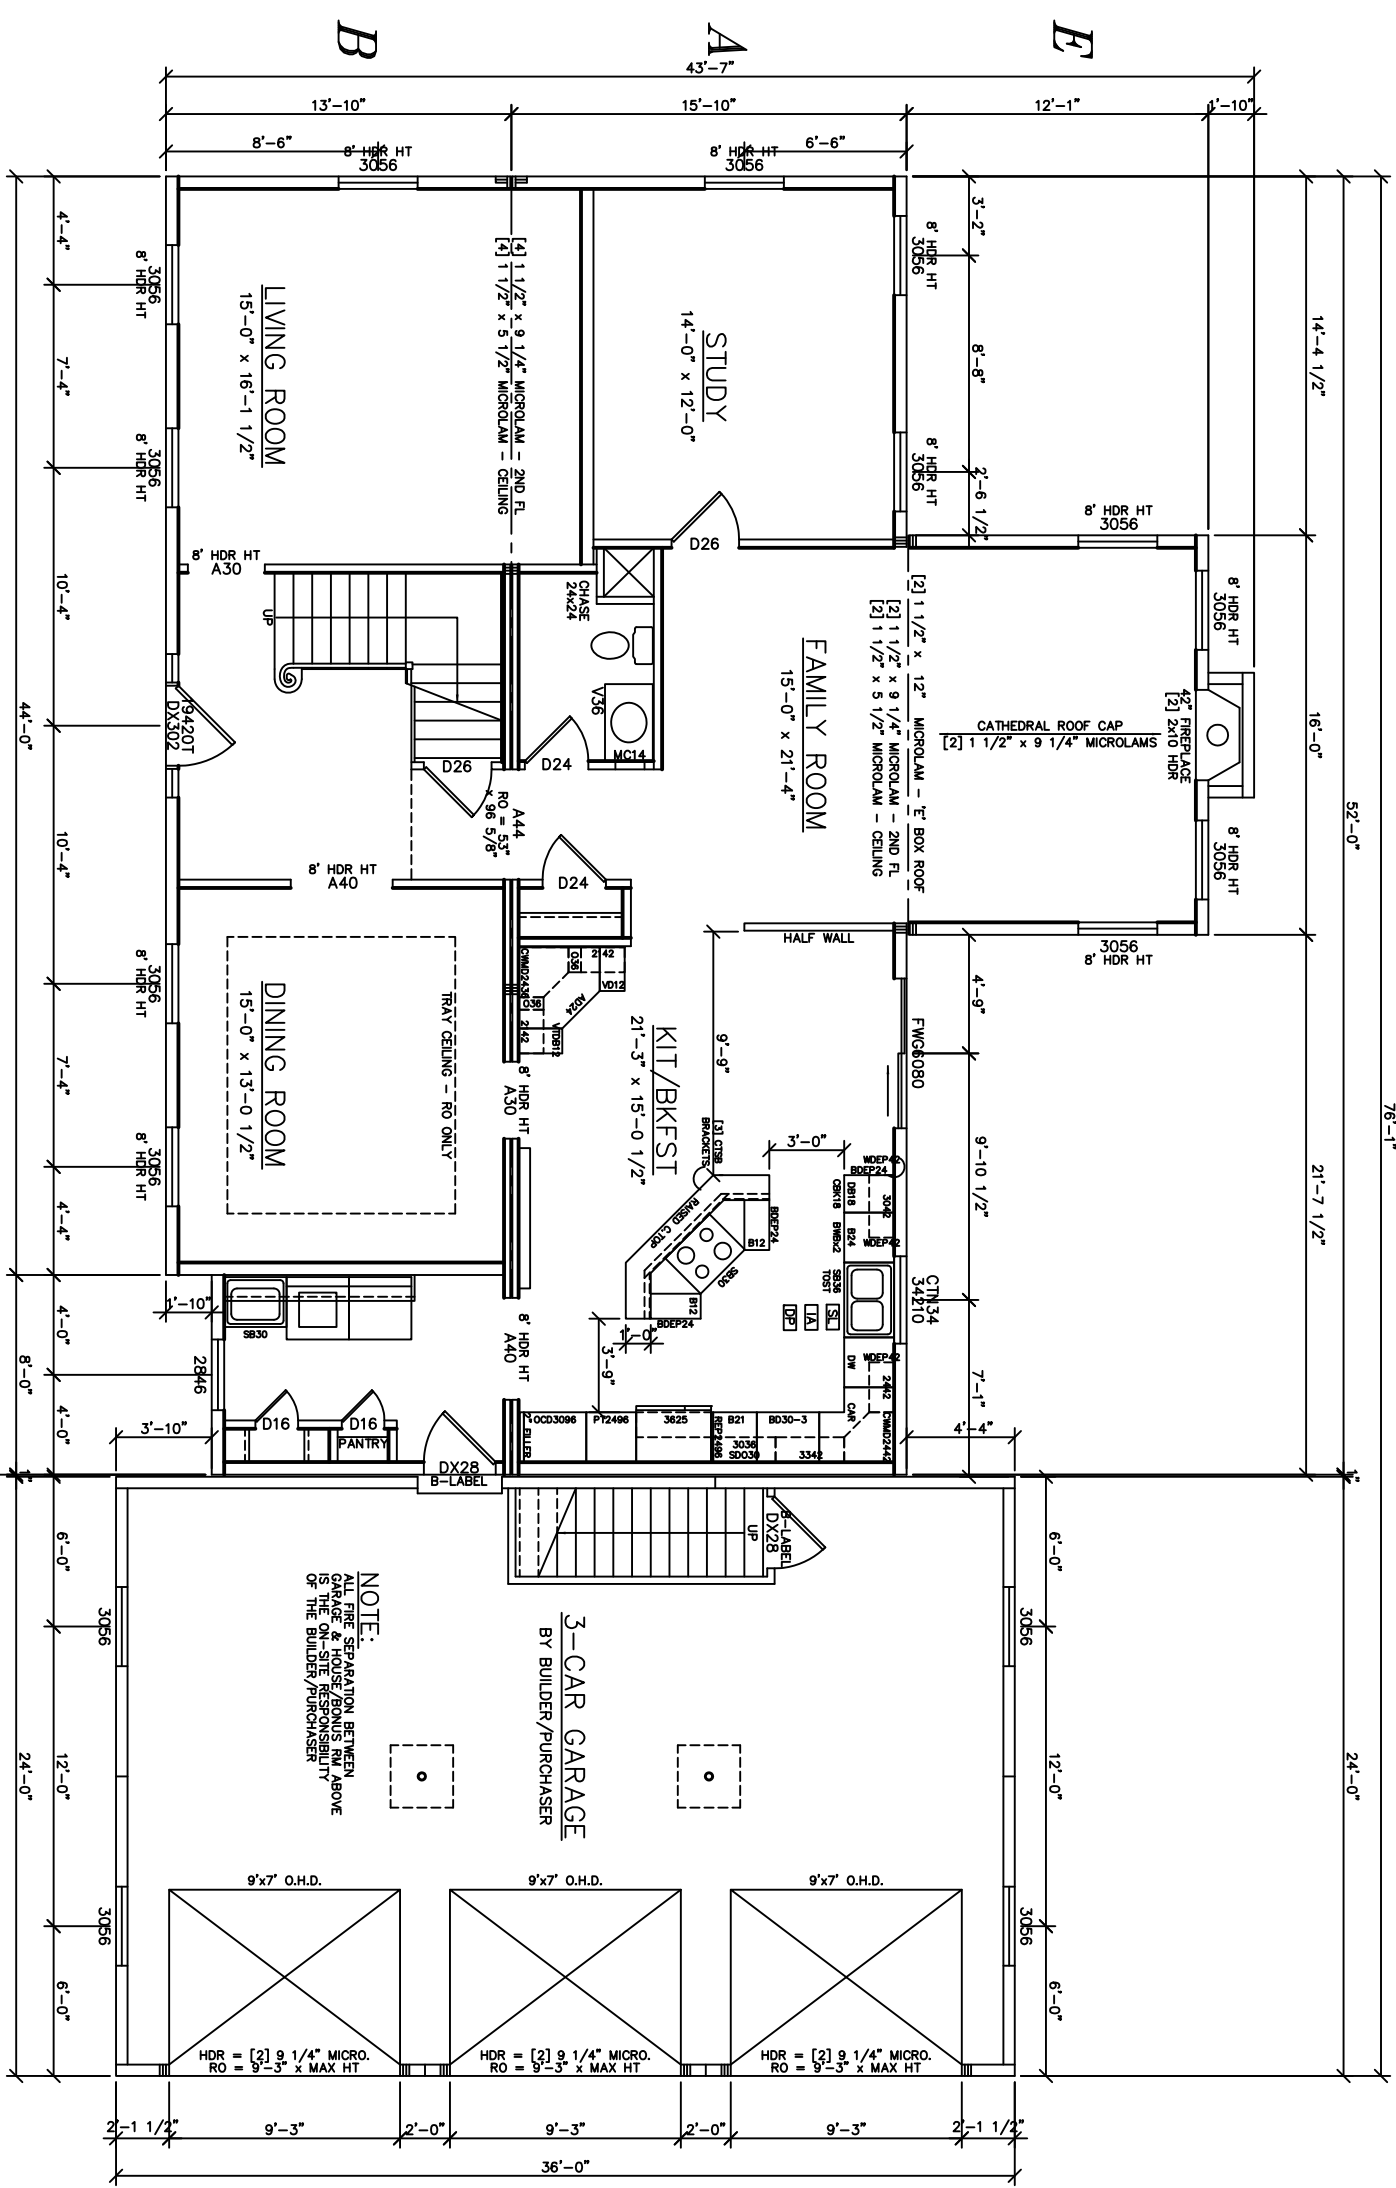


**9'-0" CEILINGS**  
ENTIRE 1ST FLOOR

NOTES: [MAIN COLONIAL ONLY]  
UPGRADE BASE & CASING  
SEMI-SOLID DOORS  
BEST LIGHT PACKAGE

SEE STANDARD NOTES & DETAILS DWG #8

USE GROUP:	BUILDER:	HOMEOWNER:	SERIAL No.	PE / RA	THIRD PARTY INSPECTION AGENCY
CONST. TYPE:		SITE:	PRODUCTION No.		
DESIGNER:	<b>GEORGETOWN - L</b> <b>FIRST FLOOR PLAN</b>			REVISION	DATE
DATE:					
SCALE: 3/16" = 1'-0"					
PAGE: <b>3A</b>					
<b>Westchester Modular Homes Inc</b> 30 Reagans Mill Road, Wingdale, New York, 12594 Tel (914)832-9400 Fax (914)832-6698			CHECK	DATE	
			STD REVISION	03/31/06	

LIGHT & VENTILATION SCHEDULE (SF)			
ROOM	AREA	LIGHT SUPPLIED	VENT SUPPLIED
MSTR BDRM	251	30.9	17.19
BEDROOM 2	196	20.6	11.46
BEDROOM 3	151	20.6	11.46
BEDROOM 4	139	11.7	6.41

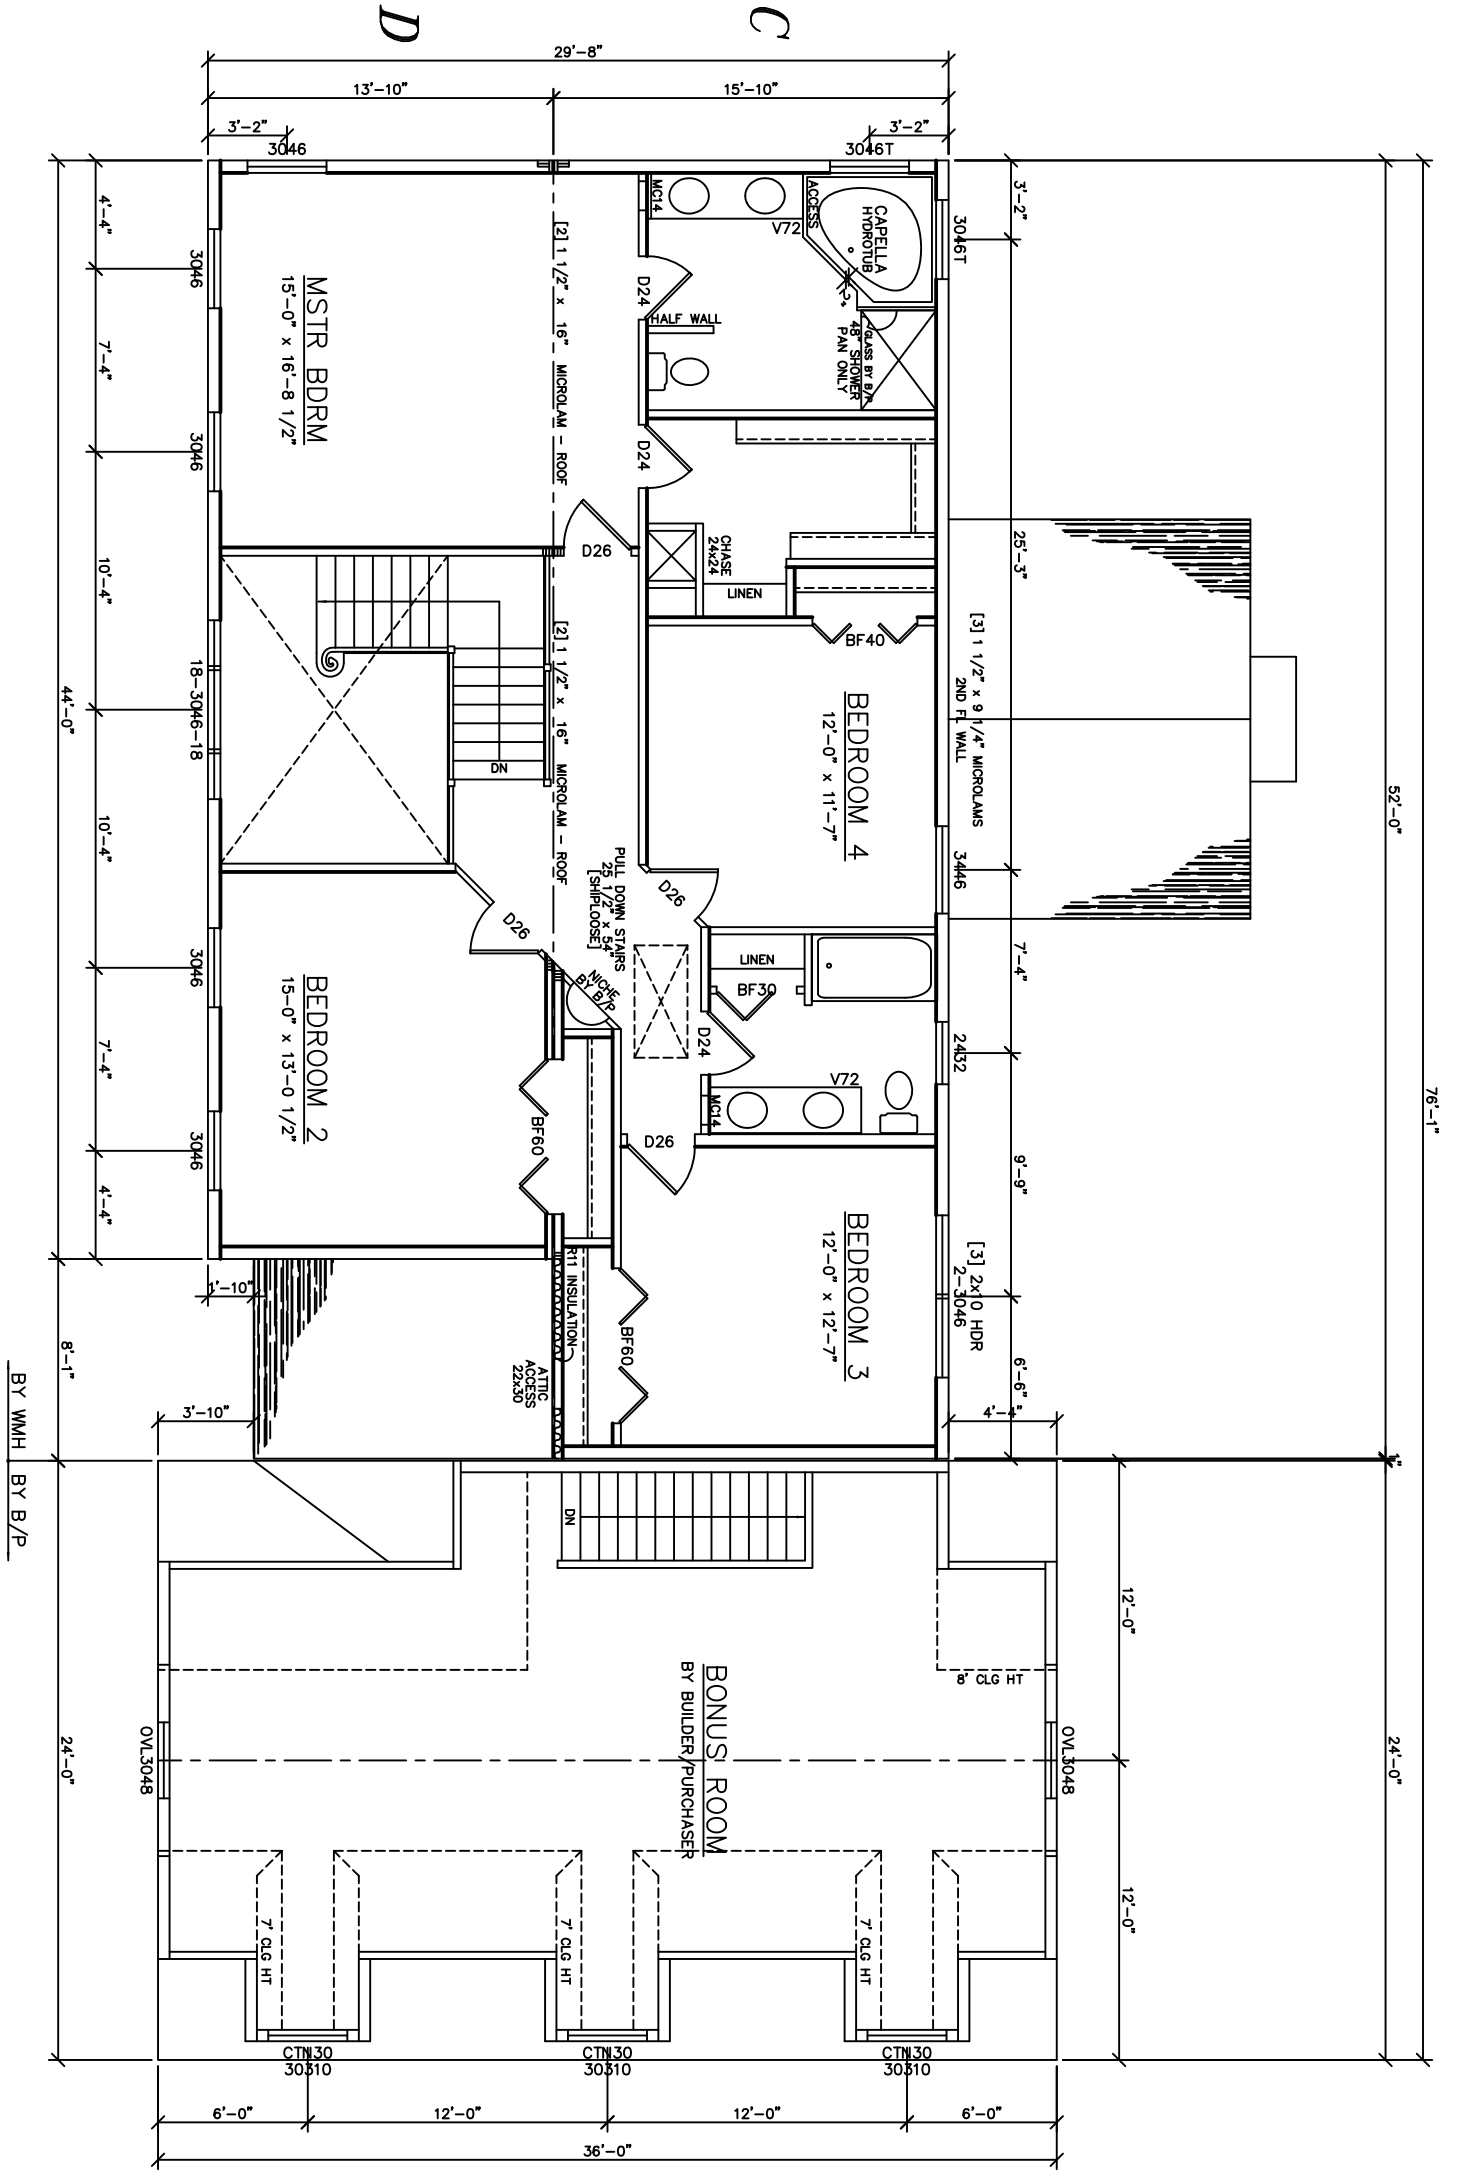

SEE STANDARD NOTES & DETAILS DWG #8

USE GROUP:	BUILDER:	HOMEOWNER:	SERIAL No.	PE / RA	THIRD PARTY INSPECTION AGENCY
CONST. TYPE:		SITE:	PRODUCTION No.		
DESIGNER:	<b>GEORGETOWN - L</b> <b>SECOND FLOOR PLAN</b>			REVISION	DATE
DATE:					
SCALE: 3/16" = 1'-0"	<b>Westchester Modular Homes Inc</b> 30 Reagans Mill Road, Wingdale, New York, 12594 Tel (914)832-9400 Fax (914)832-6698			CHECK	DATE
PAGE: <b>3B</b>				STD REVISION	03/31/06